



Z:\2020\20-173\CIVIL\CAD\20-173 6 TYPICAL SECTIONS.DWG

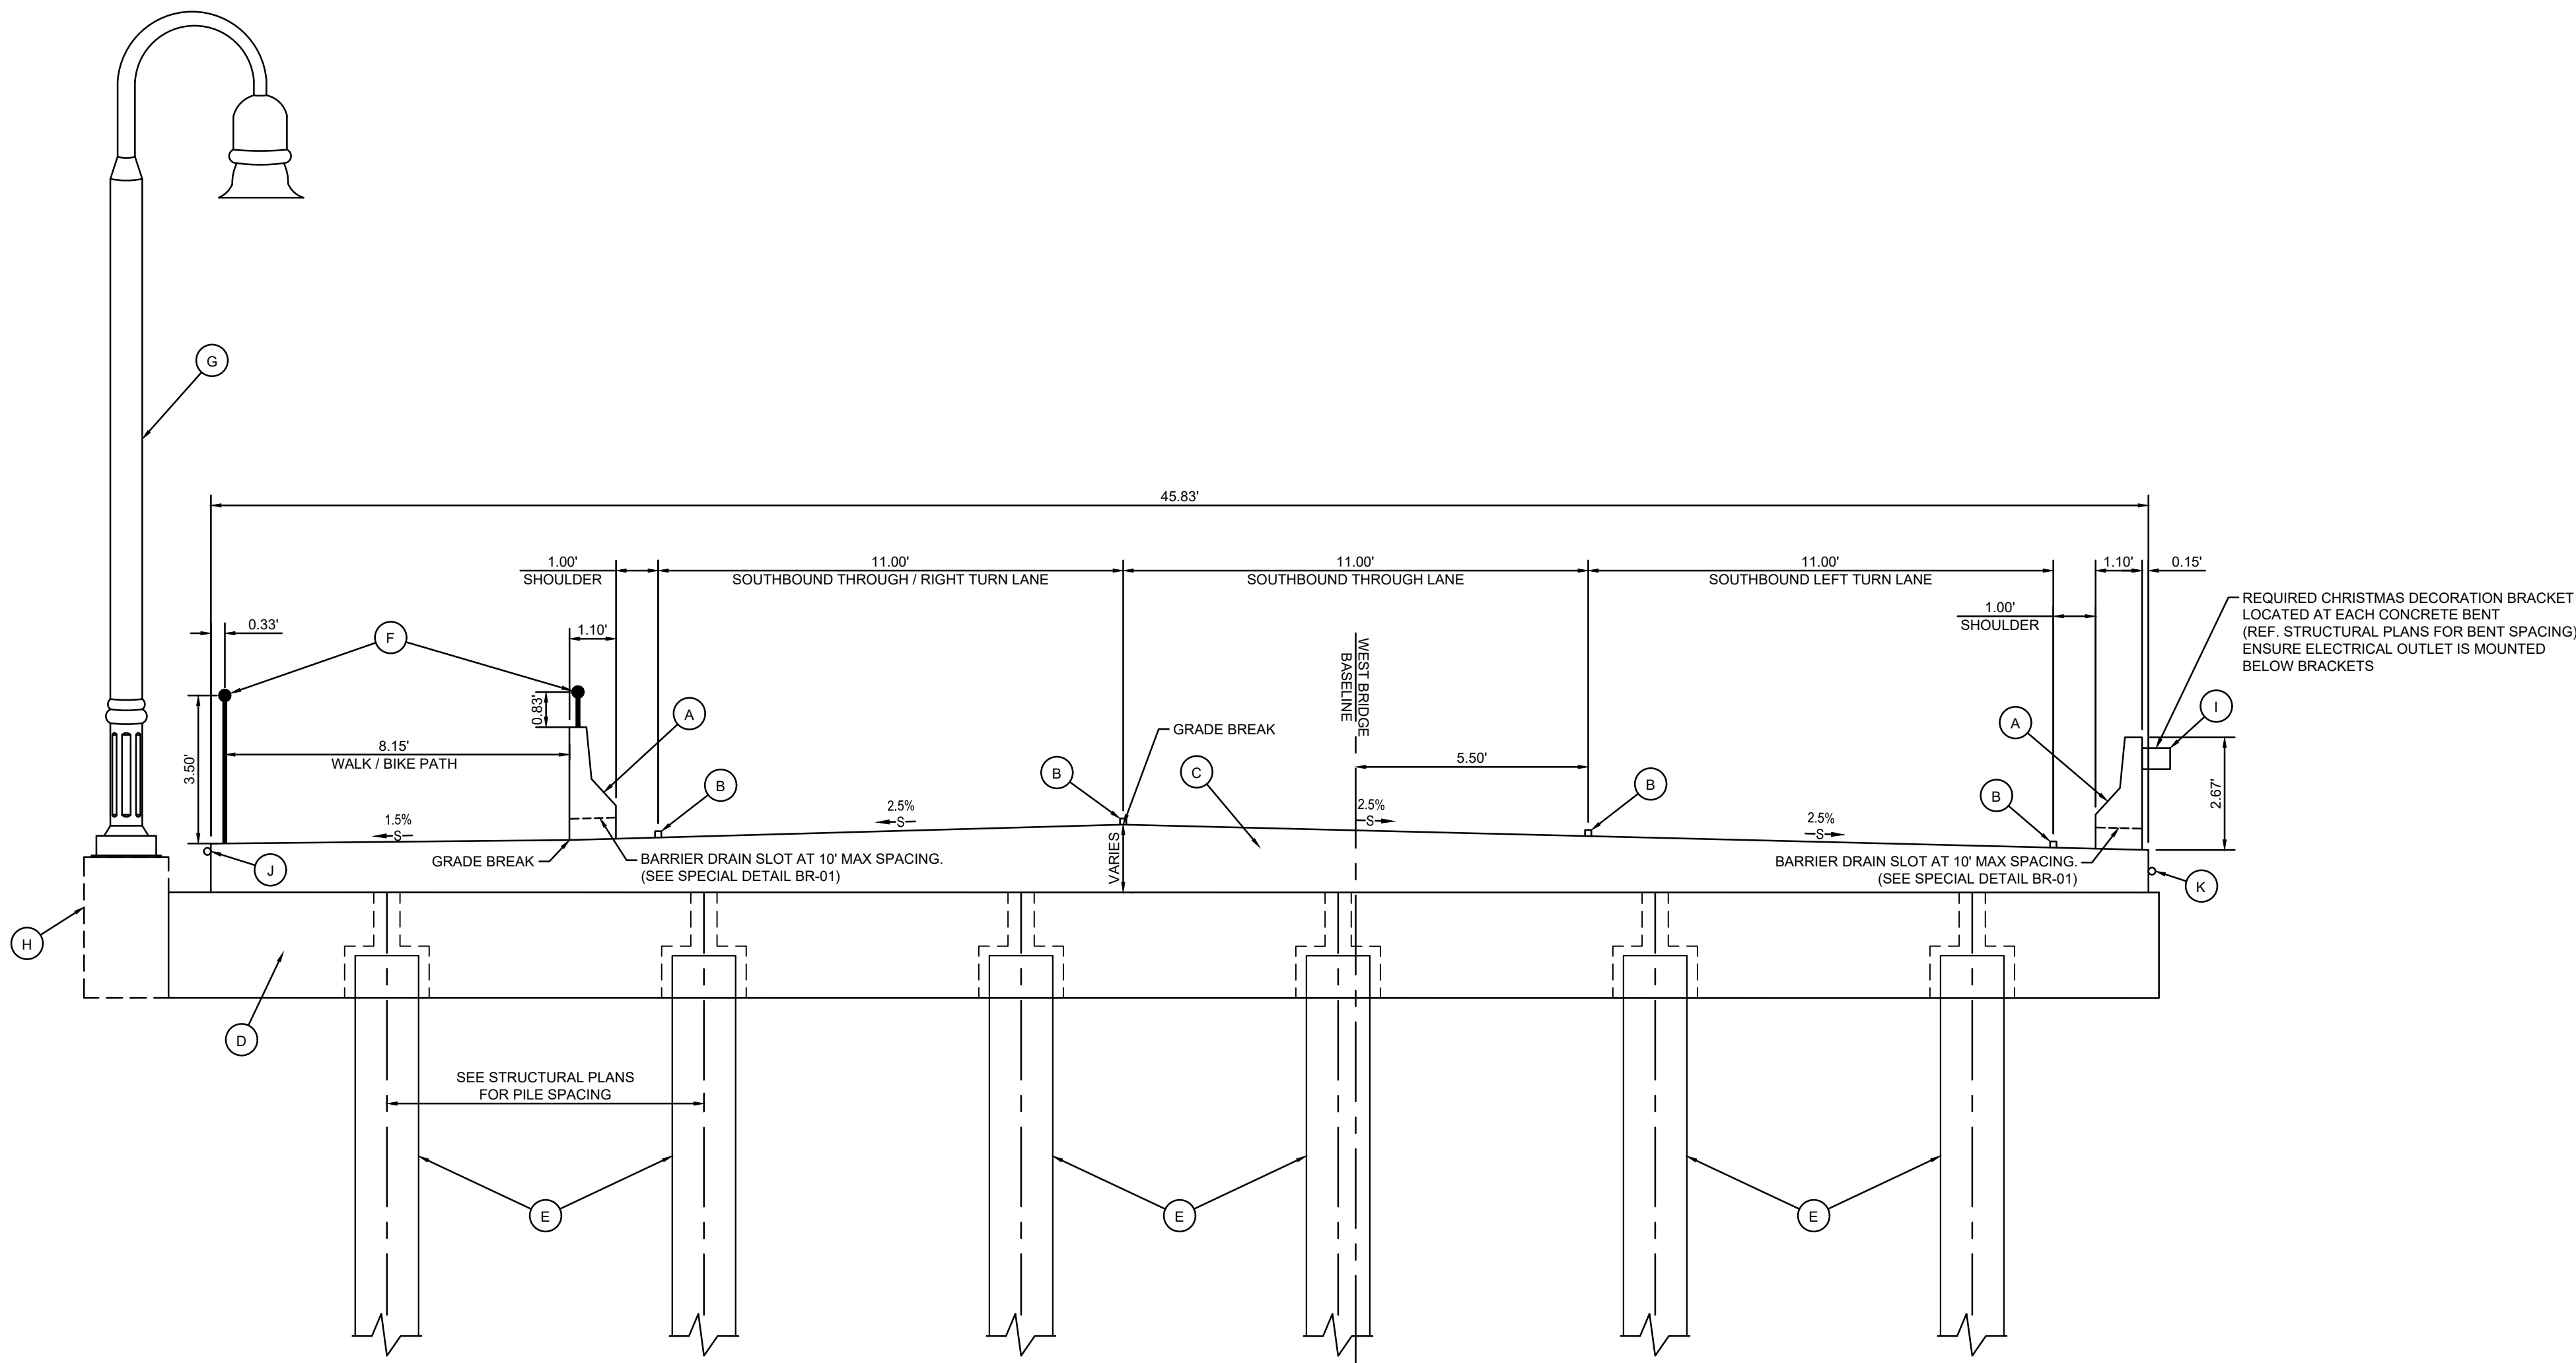

WEST BRIDGE TYPICAL SECTION
SCALE: 1" = 3'

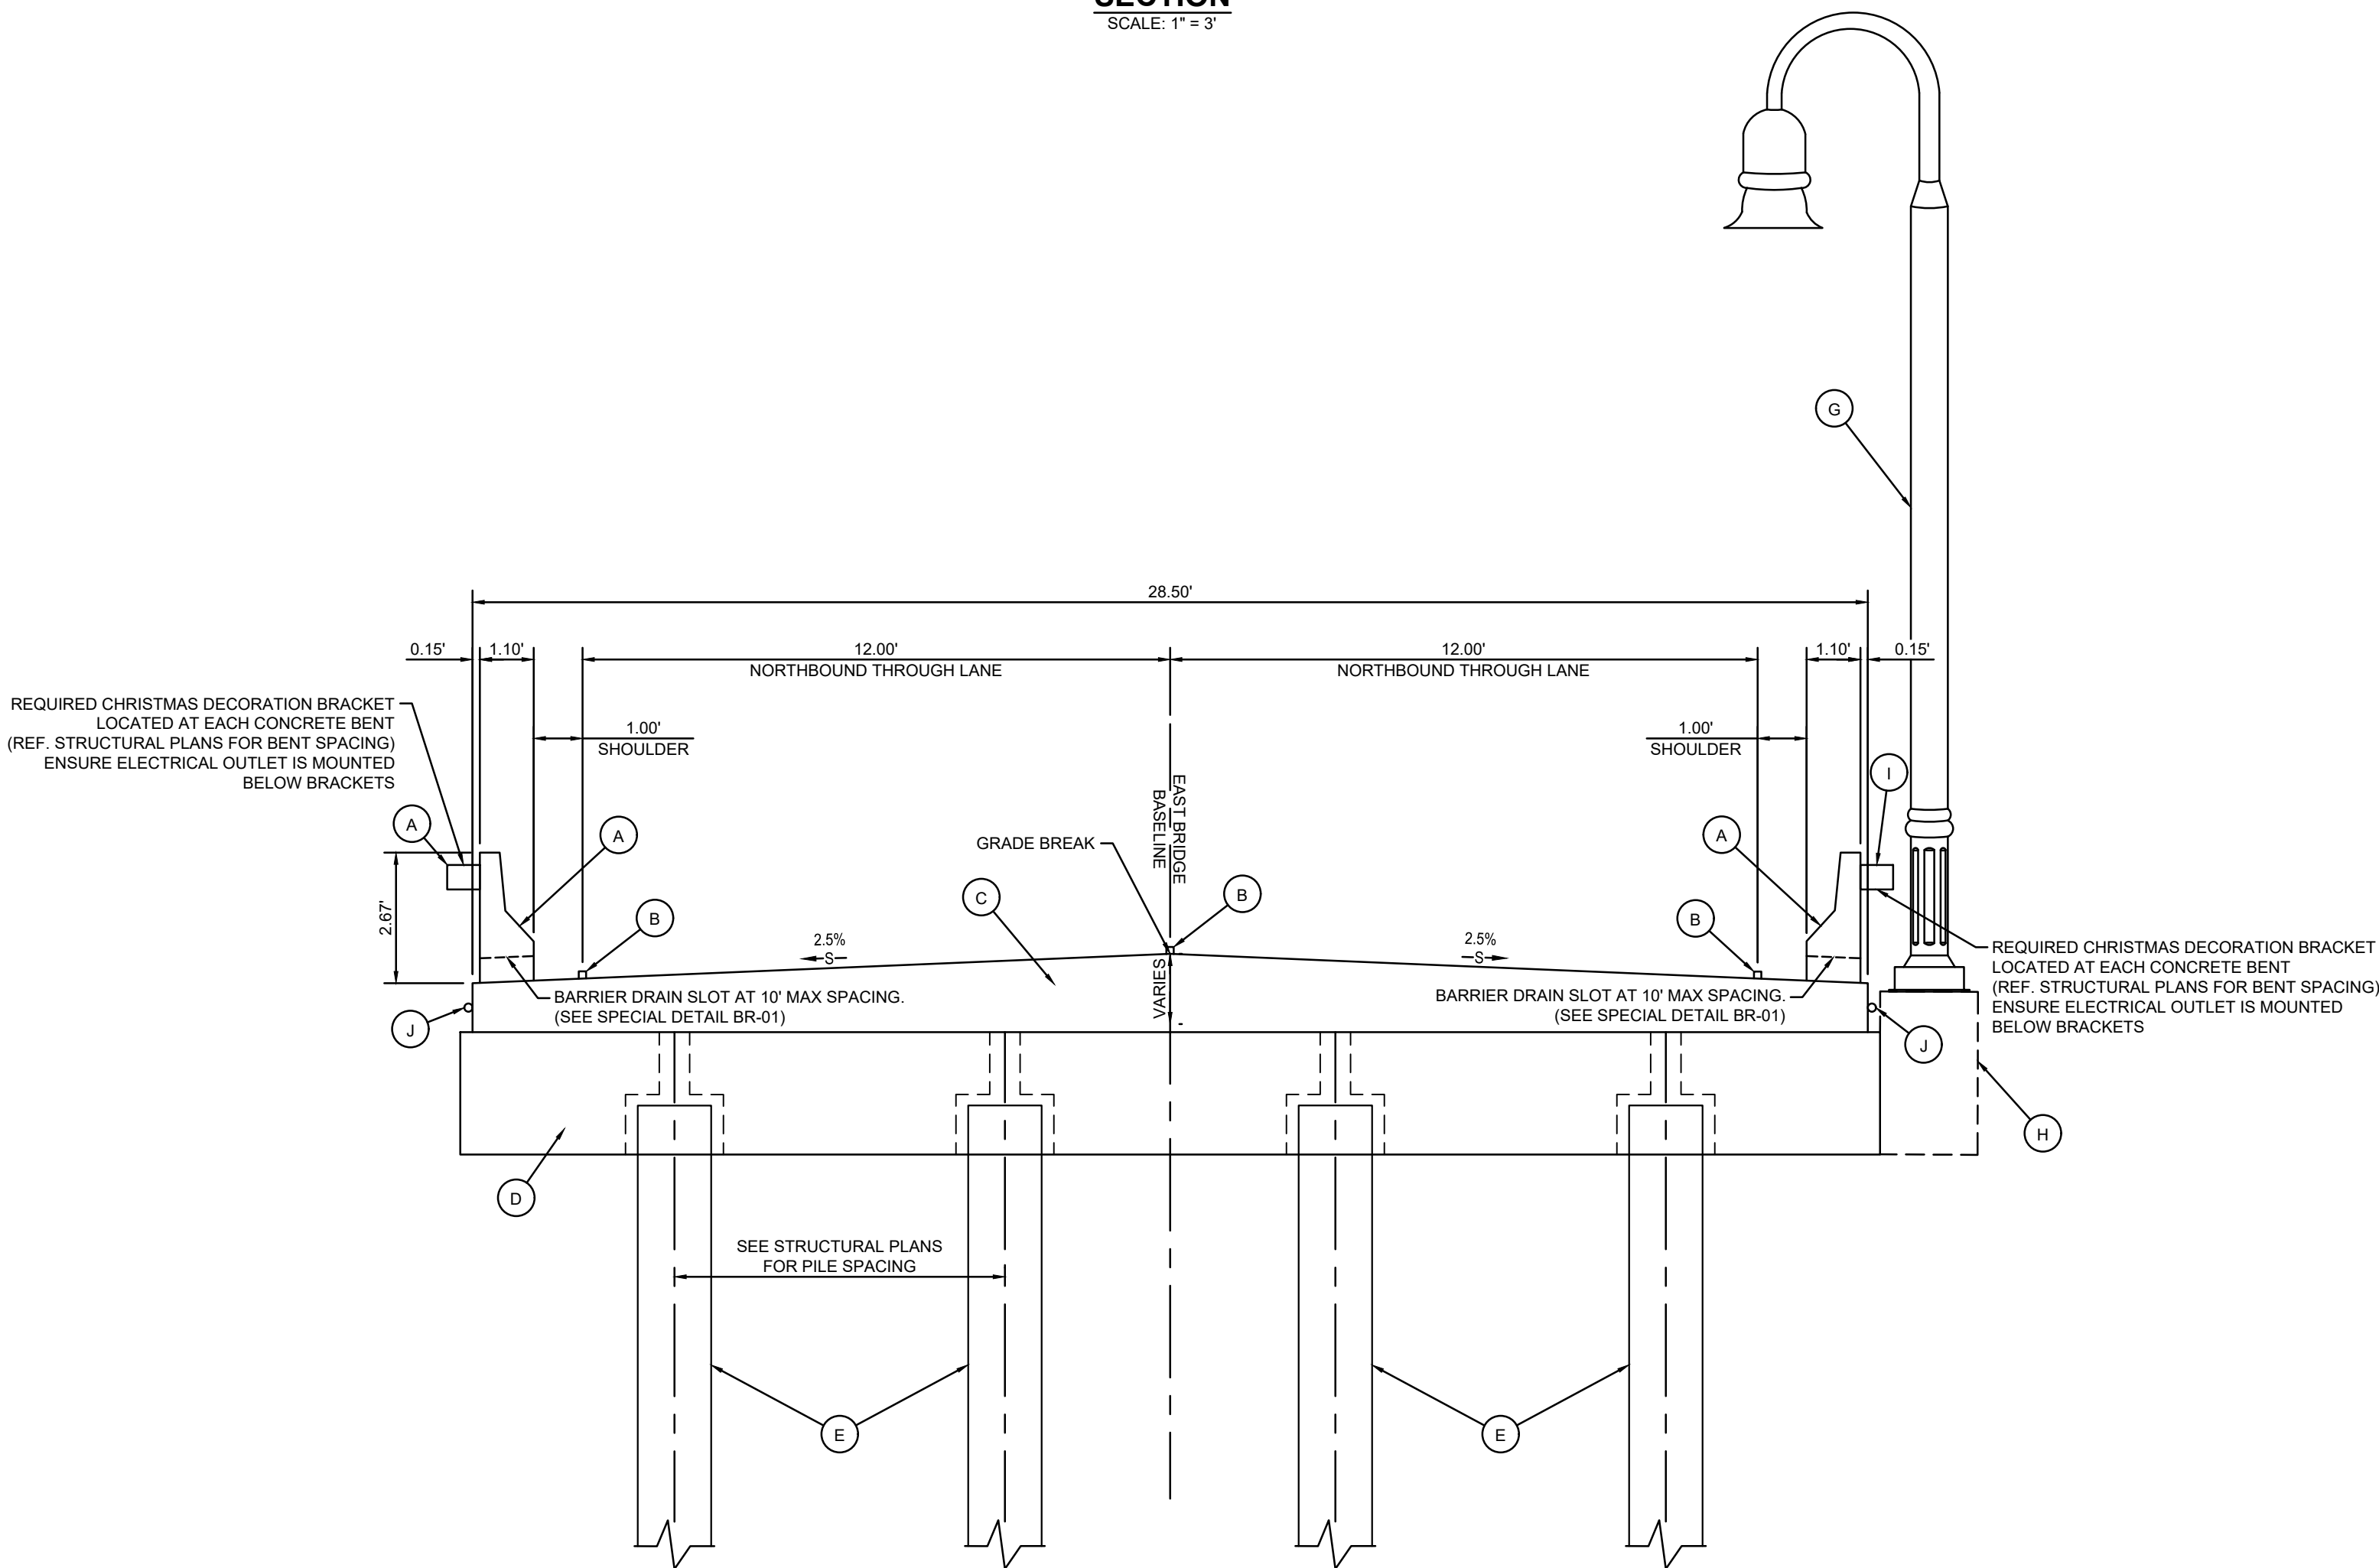

EAST BRIDGE TYPICAL SECTION
SCALE: 1" = 3'

KEYNOTE LEGEND

- (A) PRE-CAST CONCRETE BARRIER (SEE STANDARD PLAN SHEET 417 FOR DETAILS)
- (B) REQUIRED PAVEMENT MARKINGS (SEE GEOMETRIC LAYOUT AND STRIPING PLAN)
- (C) PRE-CAST CONCRETE BRIDGE DECK (SEE STRUCTURAL PLANS FOR REQUIREMENTS)
- (D) PRE-CAST CONCRETE BENT (SEE STRUCTURAL PLANS FOR REQUIREMENTS)
- (E) 18" X 18" X 95' LONG PRECAST SQUARE CONCRETE PILES (SEE STANDARD PLAN SHEET 406 FOR DETAILS)
- (F) DECORATIVE BRIDGE RAILING (SEE DETAILS)
- (G) DECORATIVE METAL LIGHTING ASSEMBLY (SEE ELECTRICAL PLANS)
- (H) PRE-CAST CONCRETE EXTENDED LIGHT POLE PILE CAP (SEE STRUCTURAL PLANS FOR REQUIREMENTS)
- (I) CHRISTMAS DECORATIVE BRACKETS (SEE DETAILS)
- (J) ELECTRICAL CONDUIT (SEE ELECTRICAL PLANS)

TYPICAL SECTIONS

CANAL BLVD. BRIDGE REPLACEMENT
LAFOURCHE PARISH
THIBODAUX, LA
FOR CITY OF THIBODAUX



PRELIMINARY NOT FOR CONSTRUCTION

PROJECT NO. 20-173

FINAL PLANS
09/18/2026


CHECKED
DRAWN BY MPR
BGD

SHEET

Z:\2020\20-173\CIVIL\CAD\20-173 7 OVERALL SITE PLANDWG




NOTE:
1. REFERENCE SHEET 1-2 AND 2-2 (TOPOGRAPHIC SURVEY)
FOR EXISTING LEGEND.

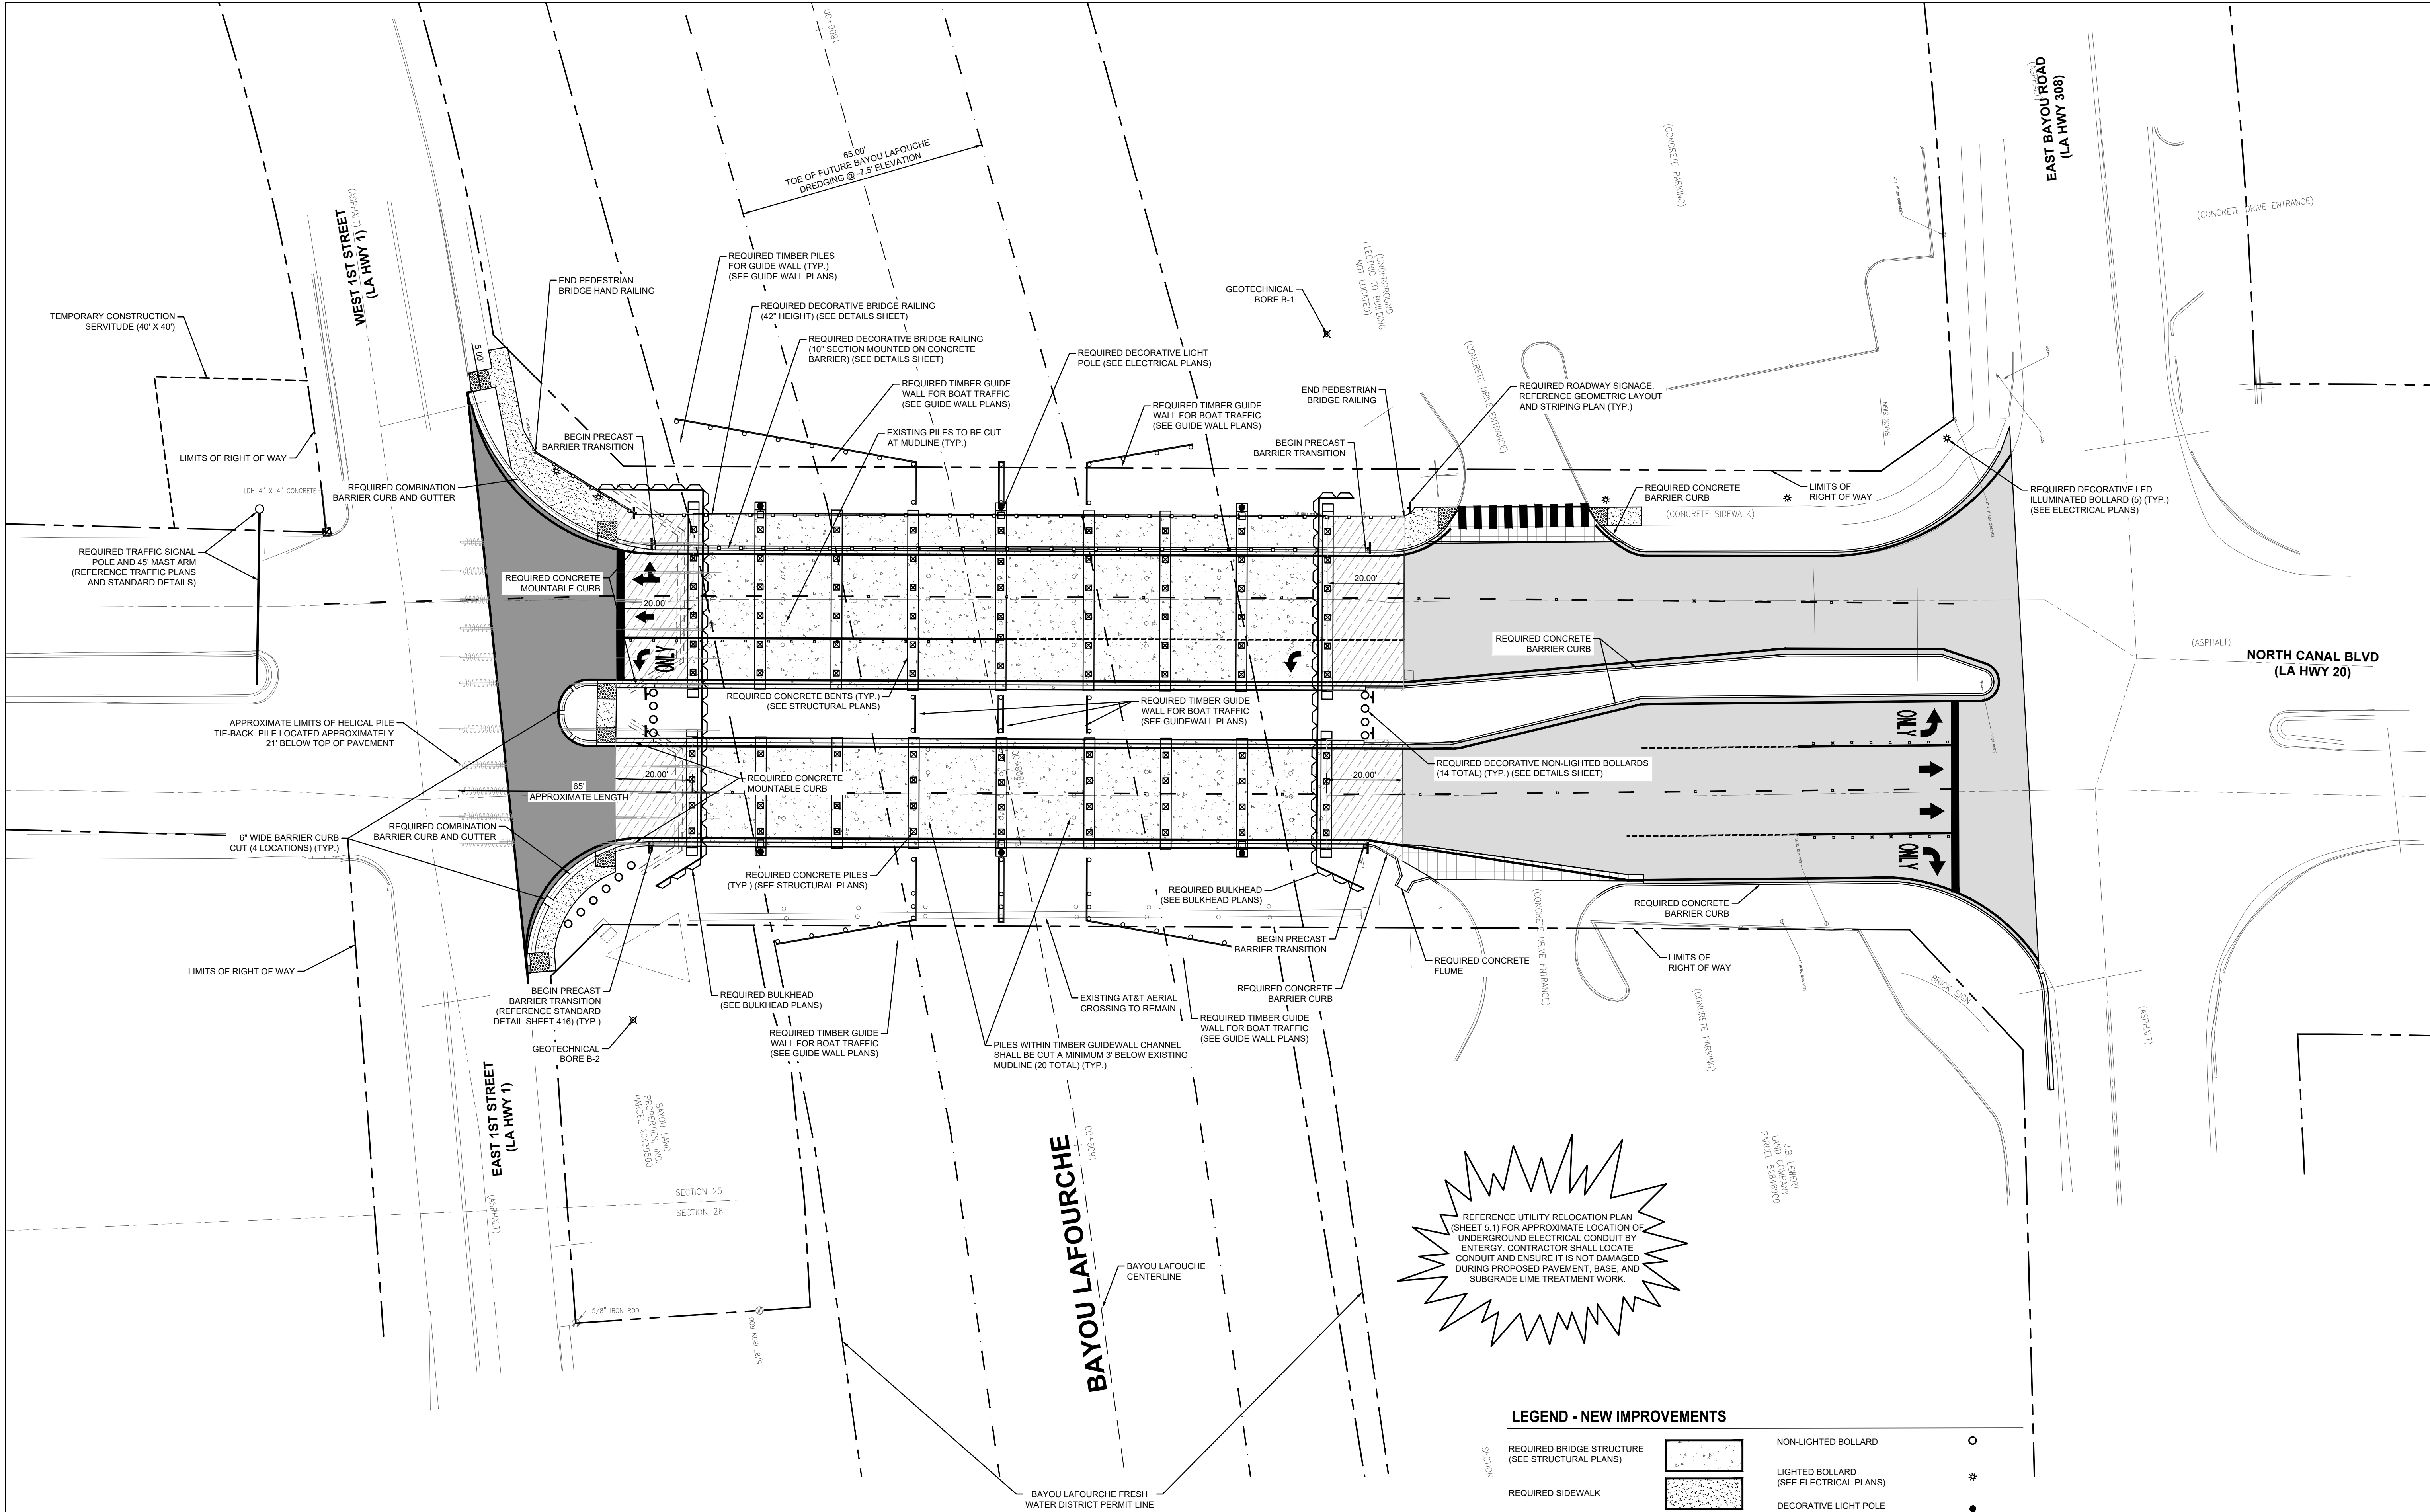

LEGEND - NEW IMPROVEMENTS

REQUIRED BRIDGE STRUCTURE (SEE STRUCTURAL PLANS)		NON-LIGHTED BOLLARD	
REQUIRED SIDEWALK		LIGHTED BOLLARD (SEE ELECTRICAL PLANS)	
REQUIRED CONCRETE ROADWAY (SEE DETAILS FOR PAVEMENT AND BASE REQUIREMENTS)		DECORATIVE LIGHT POLE (SEE ELECTRICAL PLANS)	
REQUIRED ASPHALT ROADWAY (SEE DETAILS FOR PAVEMENT AND BASE REQUIREMENTS)		CONCRETE PILE	
REQUIRED CONCRETE DRIVE (8" THICK)		TIMBER GUIDE WALL	
APPROACH SLAB (SEE STRUCTURAL PLANS)		BULKHEAD	
DETECTABLE WARNING SURFACE (SEE PED-01)		GEOTECHNICAL BORE	
		PEDESTRIAN BRIDGE RAILING	
		REQUIRED SIGNAGE	

OVERALL SITE PLAN

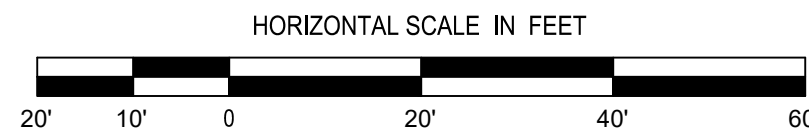

PROJECT NO. 20-173

FINAL PLANS
09/18/2026

CHECKED MPR
DRAWN BY BGD

SHEET

7


CANAL BLVD. BRIDGE REPLACEMENT

LAFOURCHE PARISH
THIBODAUX, LA
FOR CITY OF THIBODAUX

DDG
314 EAST BAYOU ROAD | THIBODAUX, LA
985.447.0090




NOTE:
1. REFERENCE SHEET 1-2 AND 2-2 (TOPOGRAPHIC SURVEY) FOR EXISTING LEGEND.

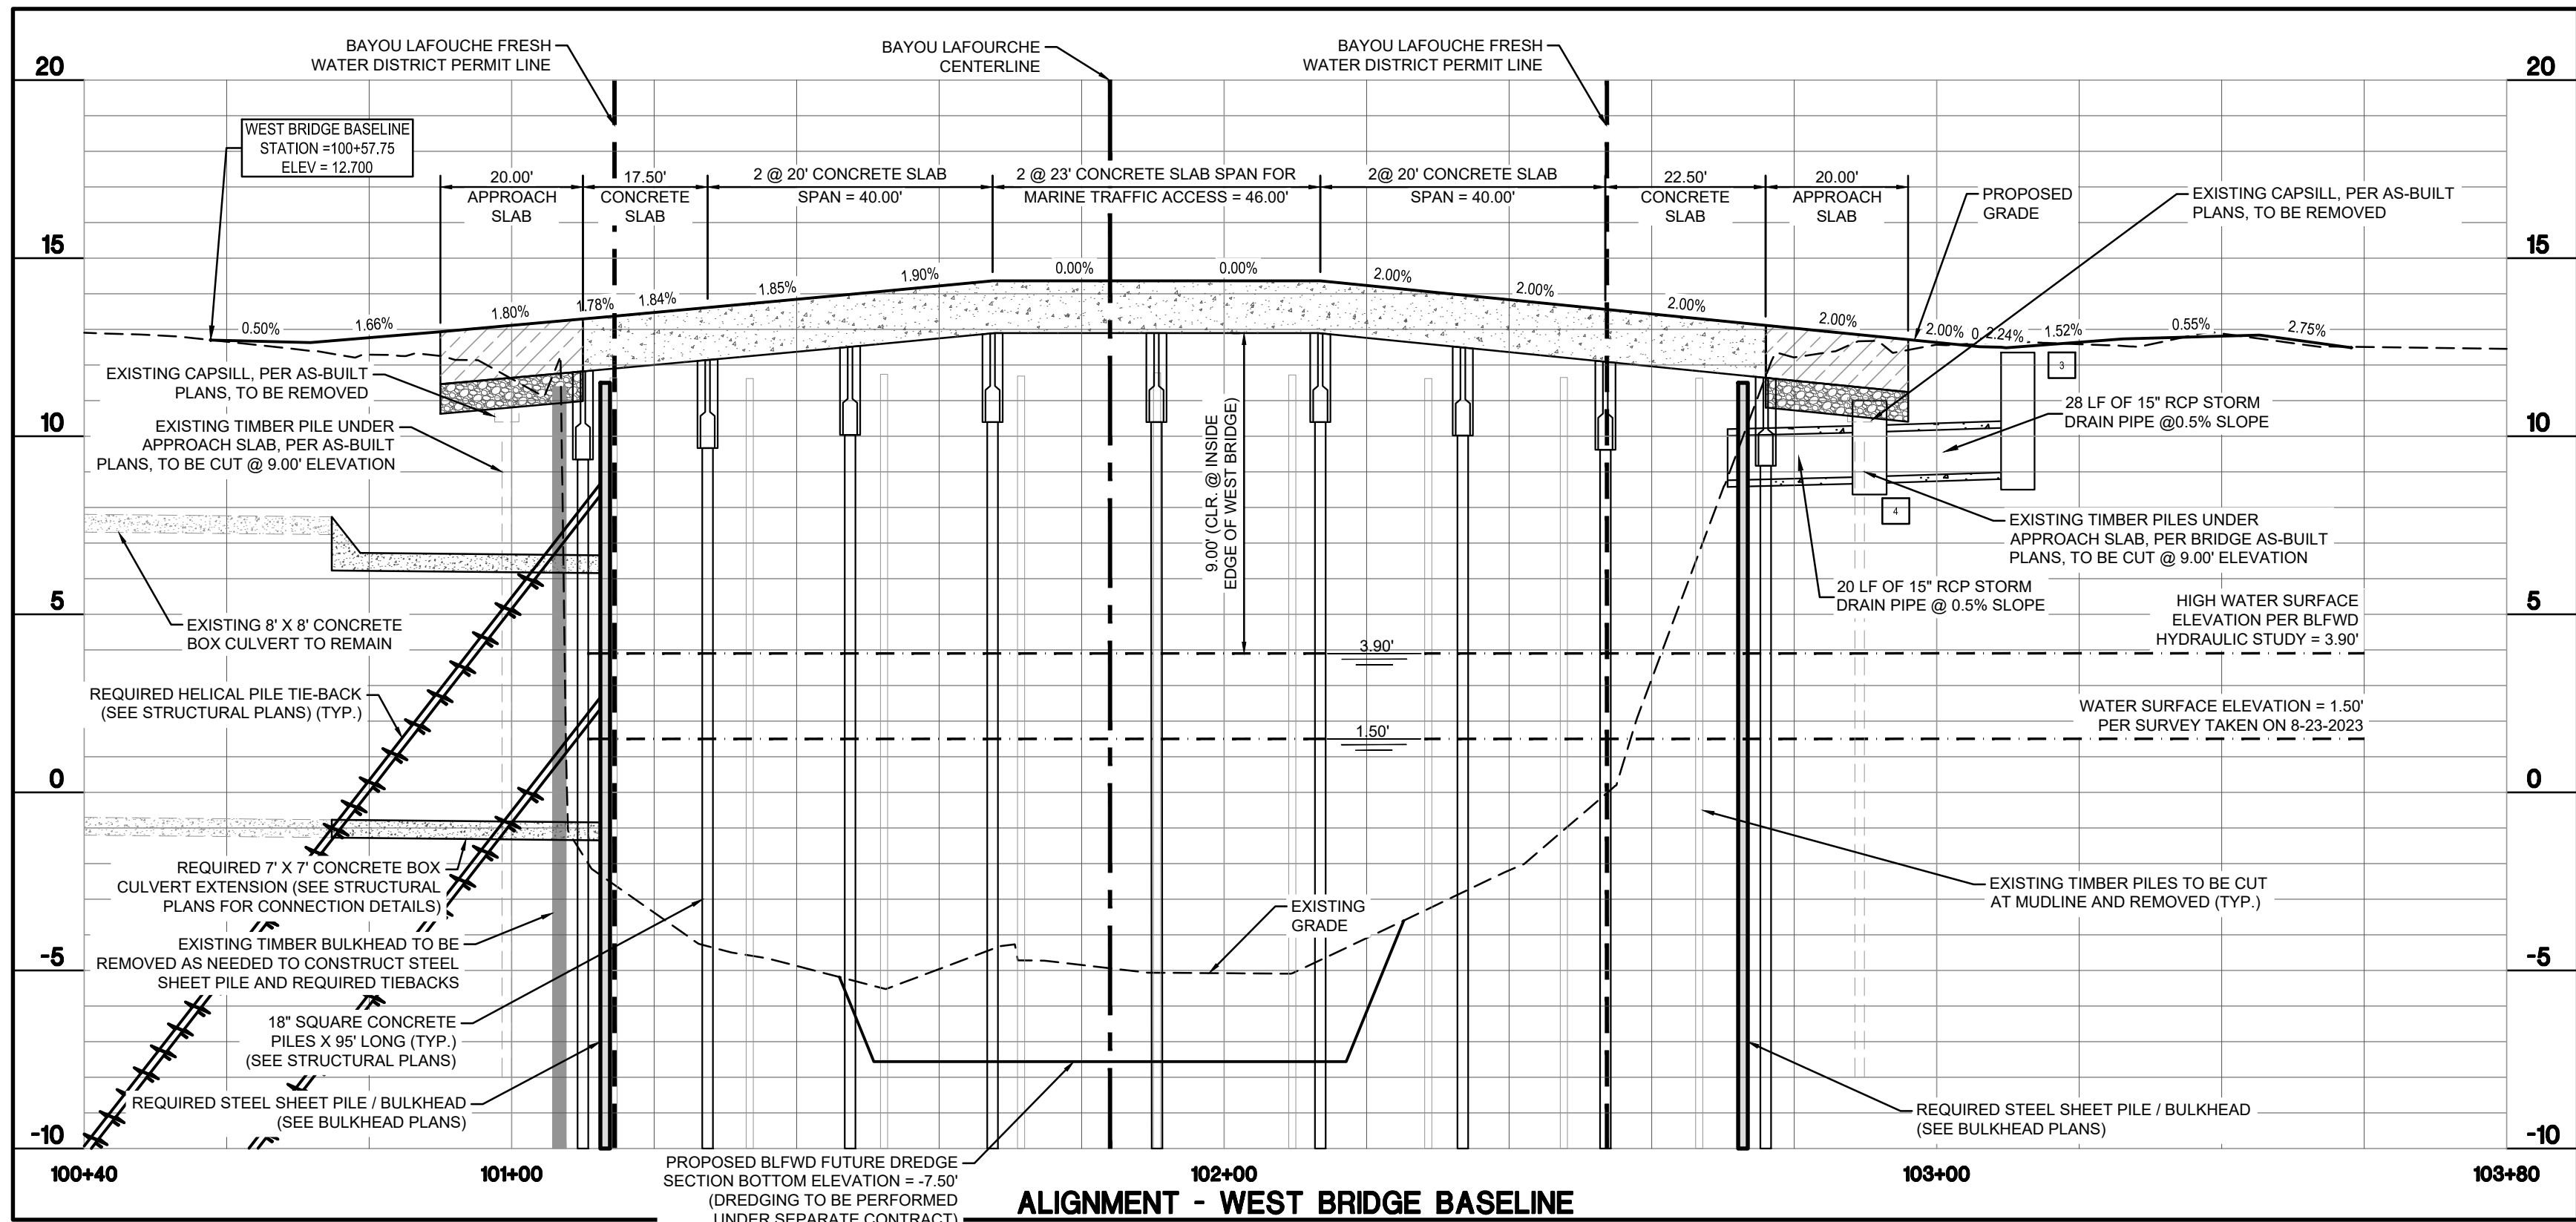

LEGEND - NEW IMPROVEMENTS

REQUIRED BRIDGE STRUCTURE		DECORATIVE LIGHT POLE	
REQUIRED SIDEWALK		CONCRETE PILE	
REQUIRED CONCRETE ROADWAY (SEE DETAILS FOR PAVEMENT AND BASE REQUIREMENTS)		GUIDE WALL	
REQUIRED ASPHALT ROADWAY (SEE DETAILS FOR PAVEMENT AND BASE REQUIREMENTS)		BULKHEAD	
REQUIRED CONCRETE DRIVE		GEOTECHNICAL BORE	
APPROACH SLAB		PEDESTRIAN BRIDGE RAILING	
CLASS II BASE (10" THICK) COURSE UNDERLAY BY TYPE D GEOTEXTILE FABRIC		REQUIRED SIGNAGE	
DRAINAGE STRUCTURE LABEL		DECORATIVE NON-ILLUMINATED BOLLARD	
		DECORATIVE LED ILLUMINATED BOLLARD	

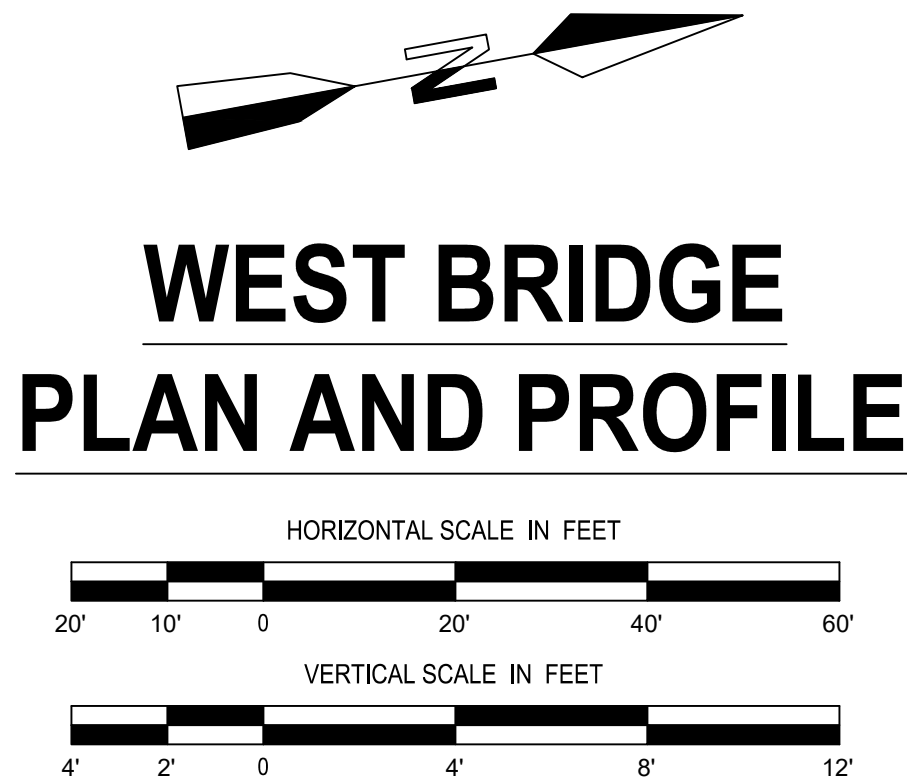

**WEST BRIDGE
PLAN AND PROFILE**

CANAL BLVD. BRIDGE REPLACEMENT
LAFOURCHE PARISH
THIBODAUX, LA
FOR CITY OF THIBODAUX



PROJECT NO.	20-173
FINAL PLANS	
09/18/2026	
CHECKED	MPR
DRAWN BY	BGD
SHEET	